


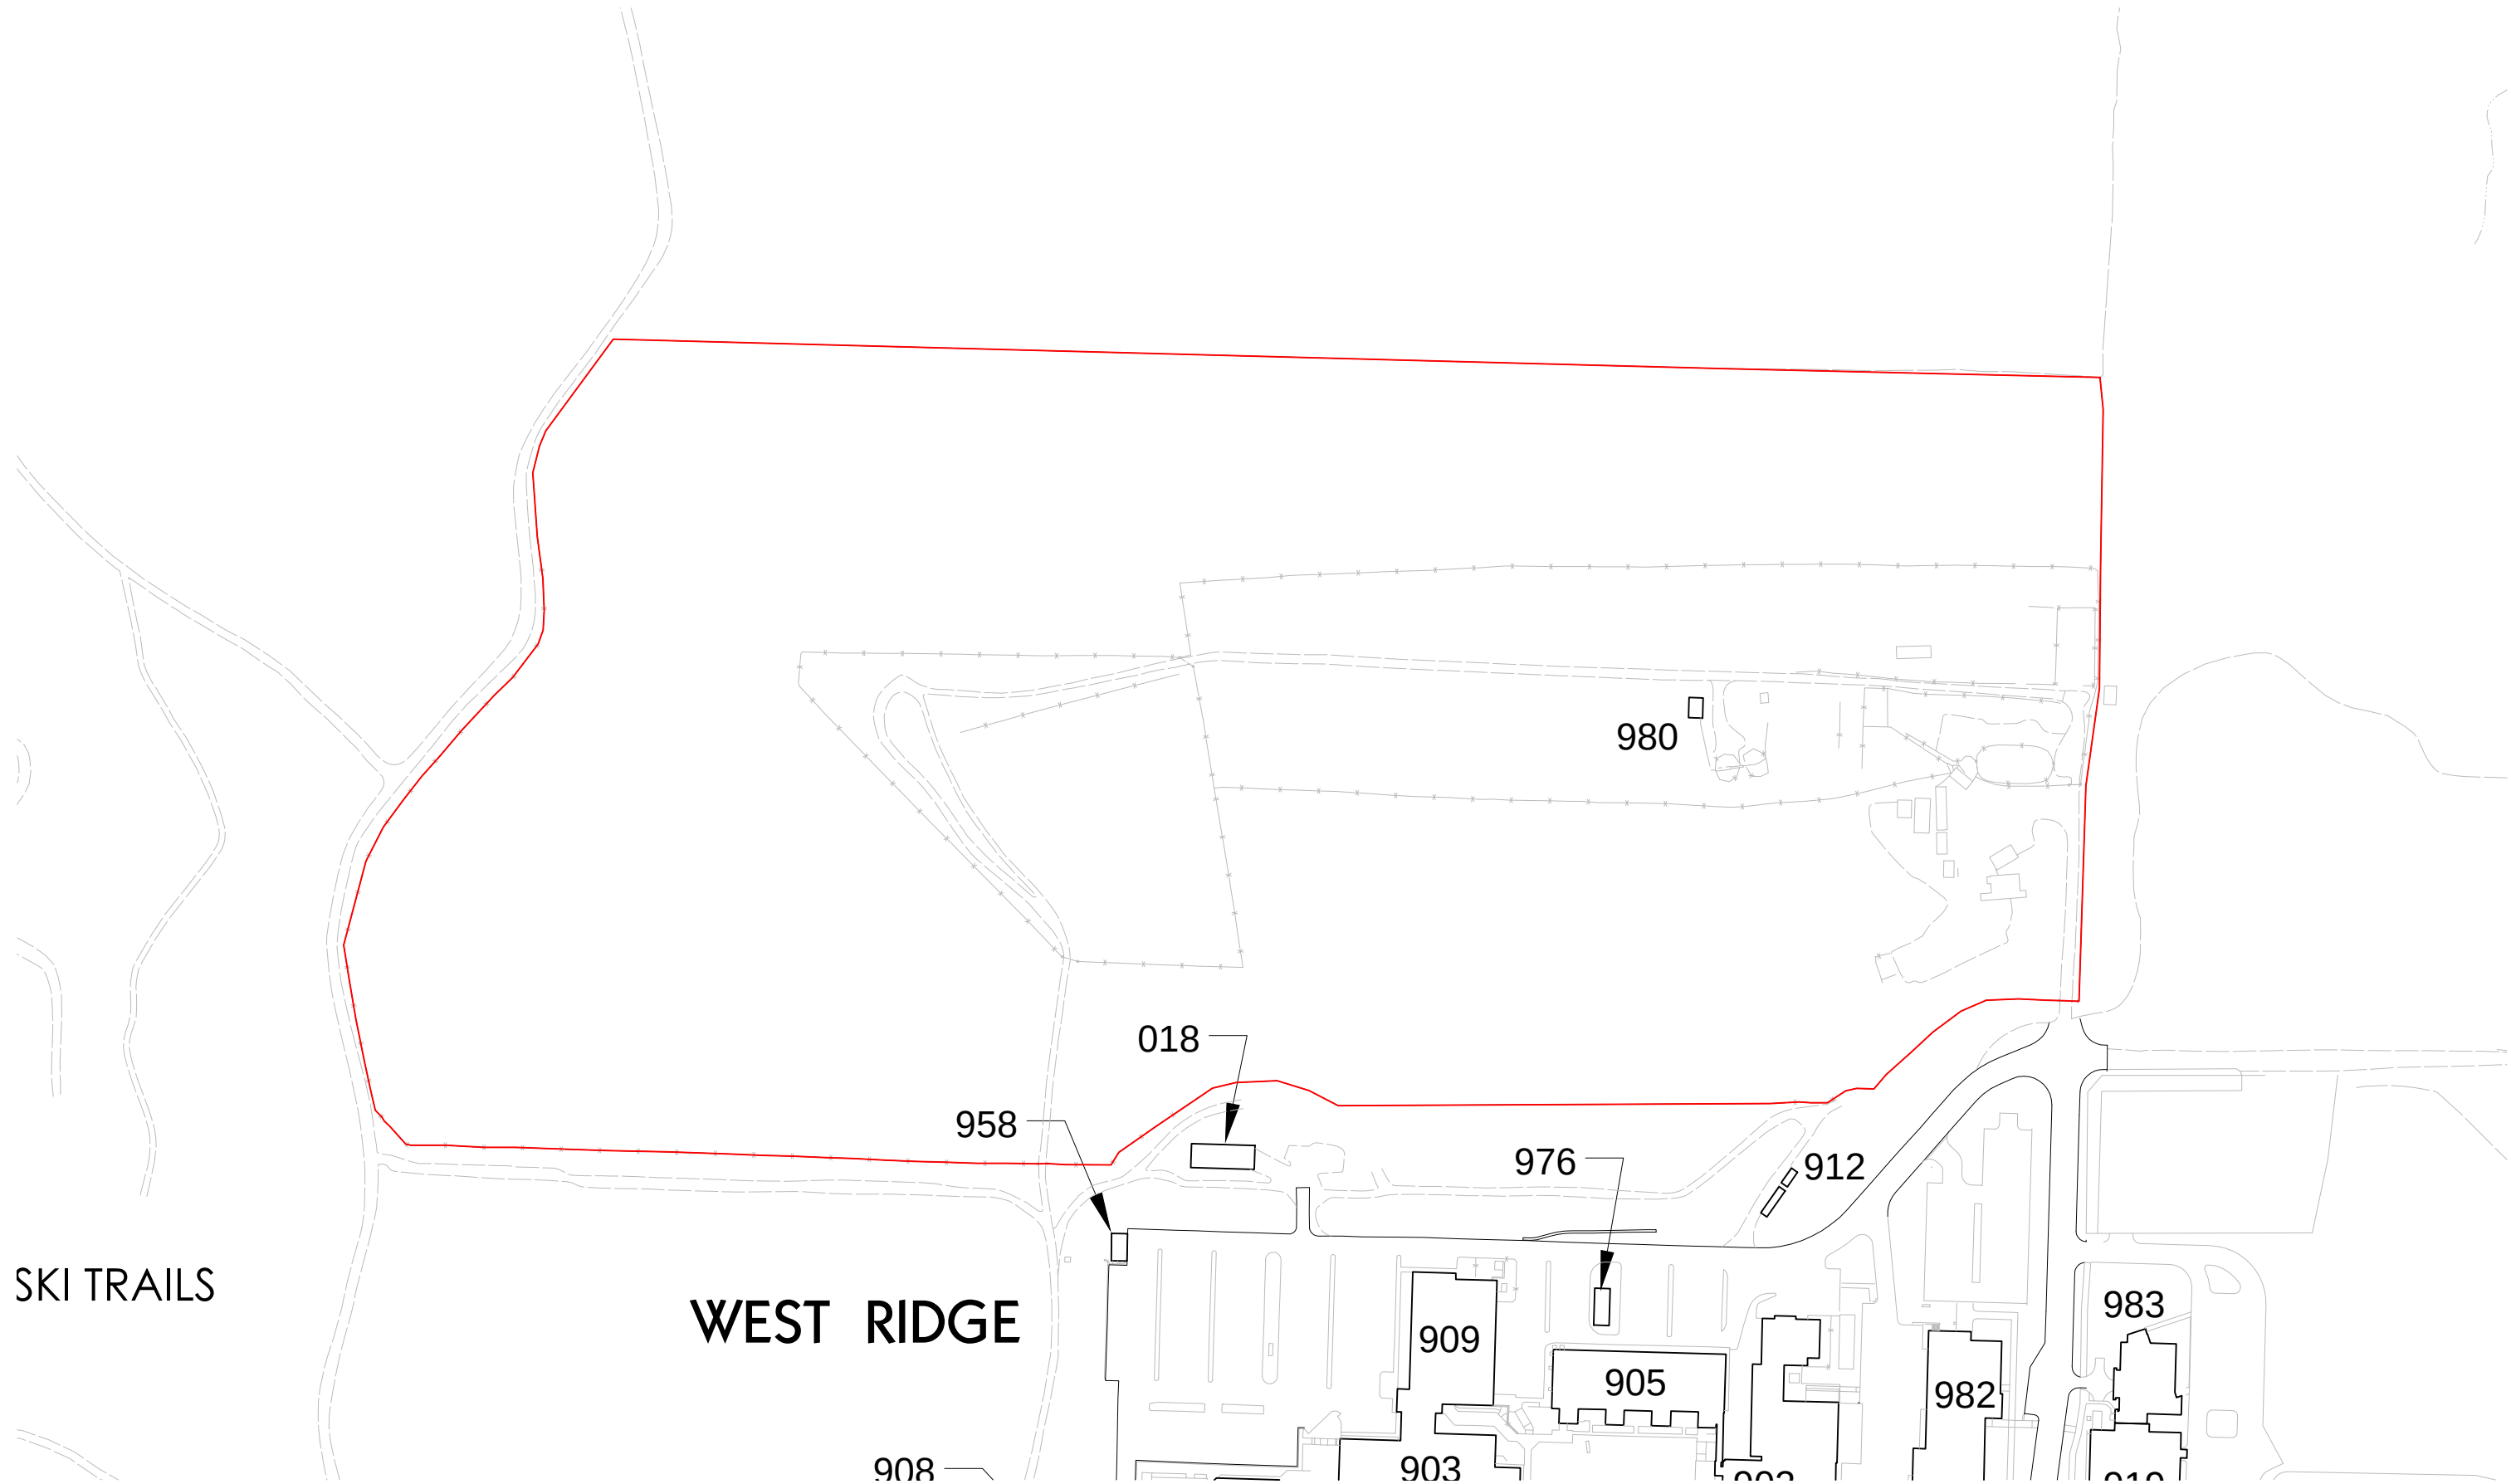

0 50 100 200 300 400 FEET

SCALE: 1" = 200' @ 11x17



BIOLOGICAL RESERVE ANIMAL FACILITY

Division of Design and Construction
P.O.Box 758160
Fairbanks, Ak 99775-8160
(907) 474-5299
UAF-DDC-CADD@alaska.edu
Prepared by Adina Keim





0 100 200 400 600 800 FEET
SCALE: 1" = 200' @ 11x17

BIOLOGICAL RESERVE ANIMAL FACILITY

Division of Design and Construction
P.O.Box 758160
Fairbanks, Ak 99775-8160
(907) 474-5299
UAF-DDC-CADD@alaska.edu
Prepared by Adina Keim

