


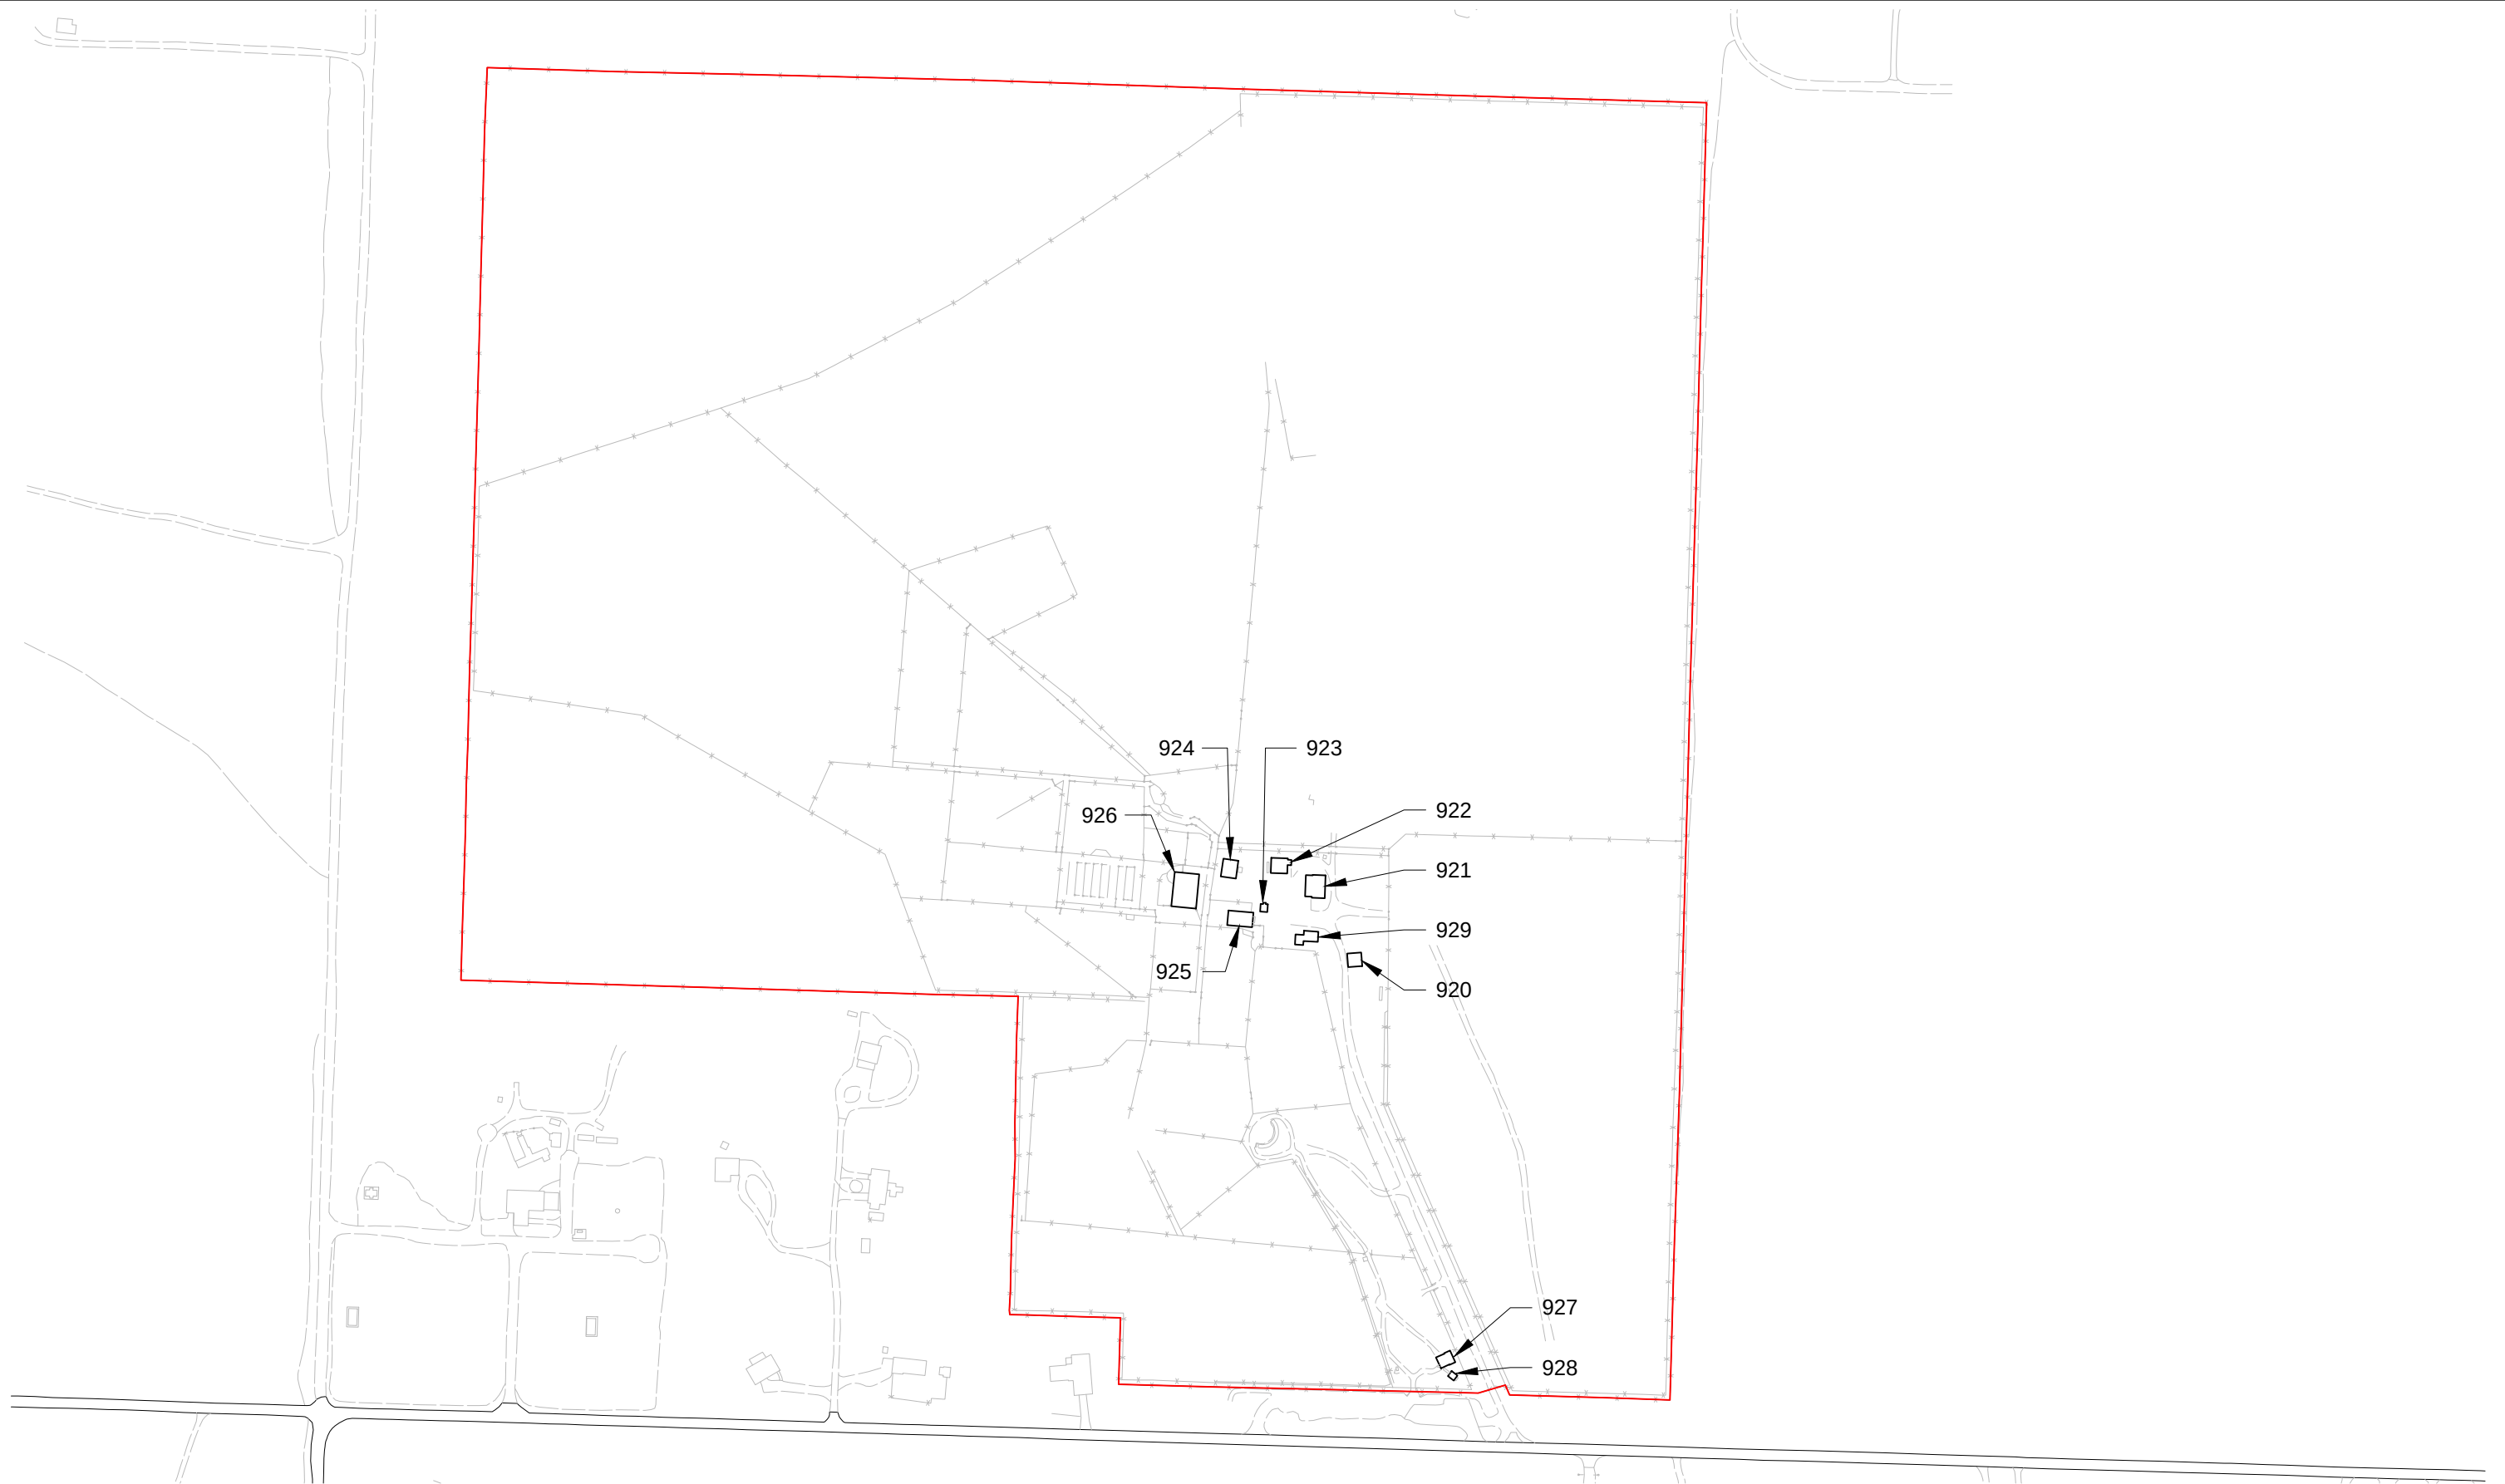

0 75 150 300 450 600 FEET

SCALE: 1" = 300' @ 11x17



BOB WHITE LARGE ANIMAL RESEARCH STATION

Division of Design and Construction
P.O.Box 758160
Fairbanks, Ak 99775-8160
(907) 474-5299
UAF-DDC-CADD@alaska.edu
Prepared by Adina Keim





0 150 300 600 900 1200 FEET
SCALE: 1" = 300' @ 11x17

BOB WHITE LARGE ANIMAL RESEARCH STATION

Division of Design and Construction
P.O.Box 758160
Fairbanks, Ak 99775-8160
(907) 474-5299
UAF-DDC-CADD@alaska.edu
Prepared by Adina Keim

