


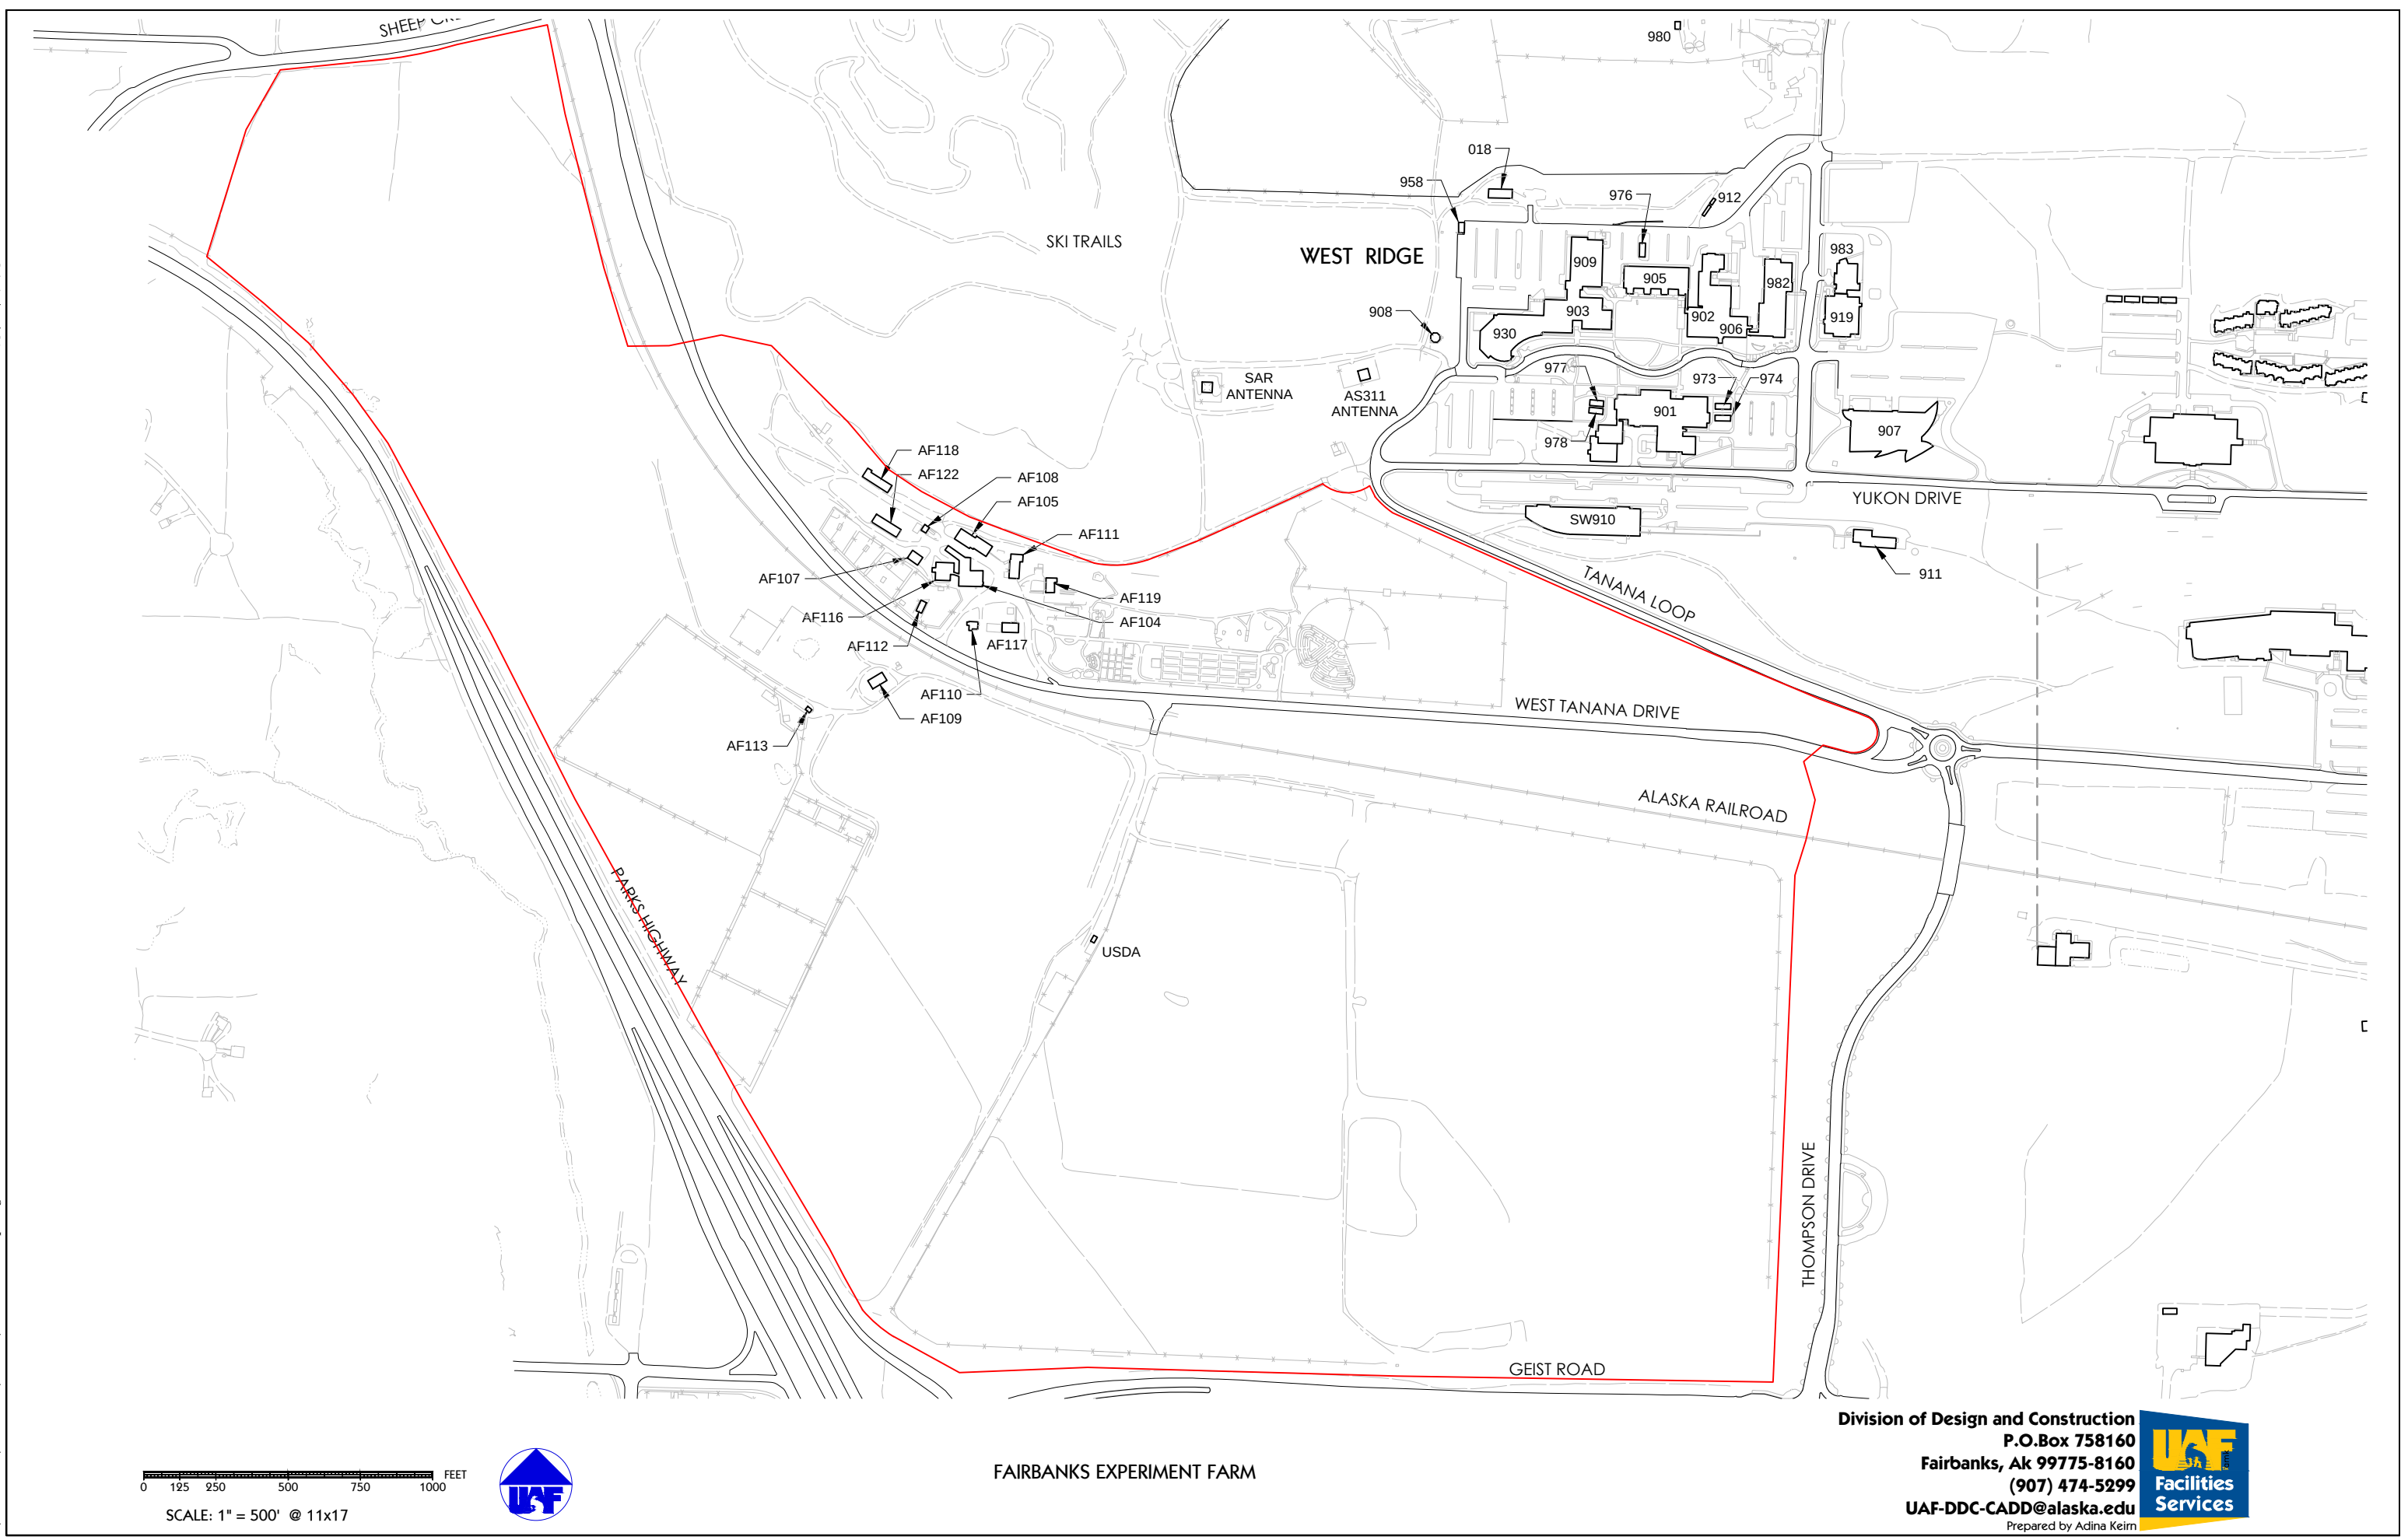


0 125 250 500 750 1000 FEET
SCALE: 1" = 500' @ 11x17



FAIRBANKS EXPERIMENT FARM

 Division of Design and Construction
P.O.Box 758160
Fairbanks, Ak 99775-8160
(907) 474-5299
UAF-DDC-CADD@alaska.edu
Prepared by Adina Keim





FAIRBANKS EXPERIMENT FARM

Division of Design and Construction
P.O.Box 758160
Fairbanks, Ak 99775-8160
(907) 474-5299
UAF-DDC-CADD@alaska.edu
Prepared by Adina Keirn

